

CCTV

I FIRE EQUIPMENT

!! EMERGENCY LIGHTING

FE FIRE EXIT

● BREAK GLASS CALL POINT

XX REMOVE (KNOCKED THROUGH)



**NOTES**

Drawing for planning only  
All measurements to be checked on site

Revision	Description	Date
A	Line 28 added	21.05.24
B	Minor amendments	22.05.24

project 25-26 THE PARADE  
project no. 1396

client MR BROWN


drawing PROPOSED GROUND FLOOR PLAN

drawing no. 05  
revision B

status PLANNING

scale 1:50@A1  
date 03.05.24

drawn by GM/AB

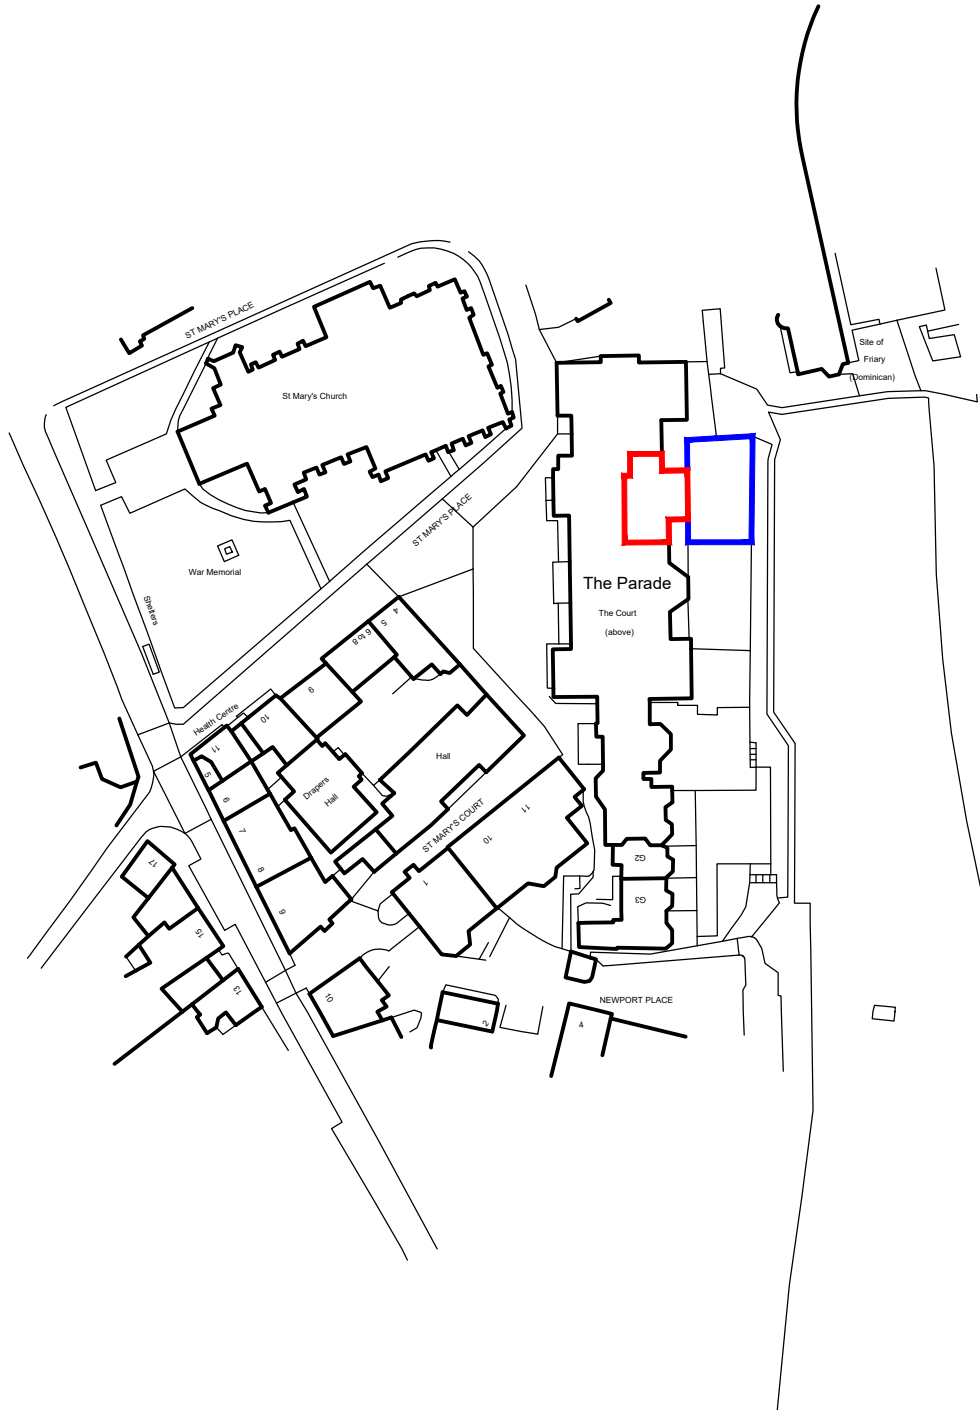

Red line denotes licenced area  
 Blue line denotes consumption area

**NOTES**  
 Drawing for planning only  
 All measurements to be checked on site

Revision	Description	Date
A	Blue line added	28.06.24

**project**  
 25-26 THE PARADE

**project no.**  
 1396

**client**  
 MR BROWN

 
**drawing**  
 LOCATION PLAN (LICENCING)

**drawing no.**      **revision**  
**06**                      **A**

**status**  
 PLANNING

**scale**                      **date**  
 1:1250@A4              21.06.24

**drawn by**  
 AB



**MOSS. CO.** LLP.  
 BROOKGATE HALL - PLEALEY - SHREWSBURY - SY5 0UY  
 Tel: 01743 588230  
 E-mail: info@mosscompany.co.uk